

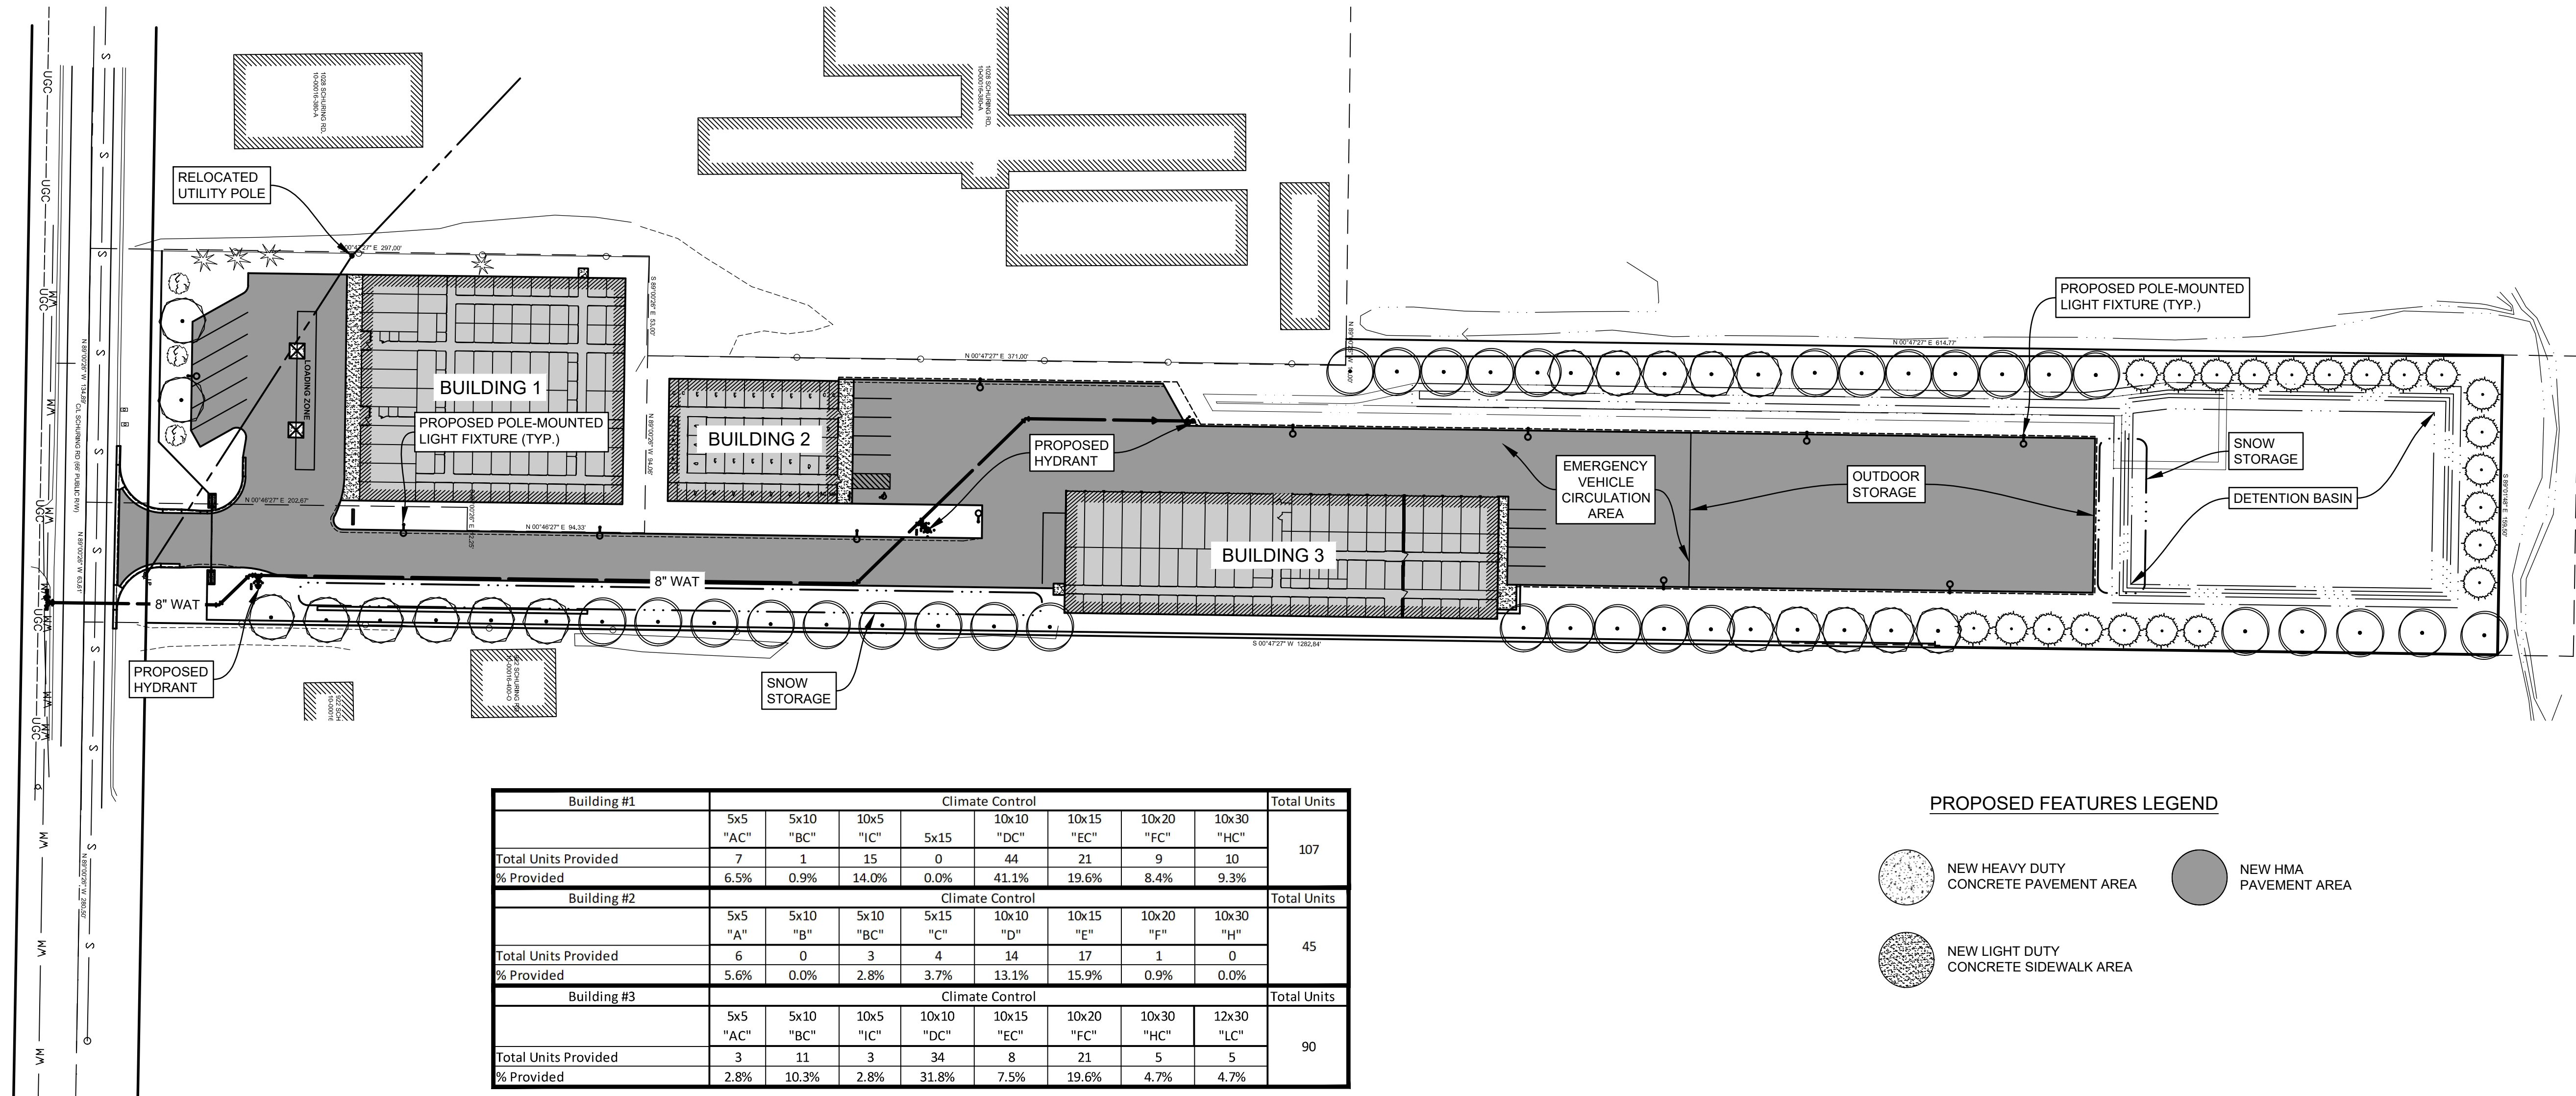


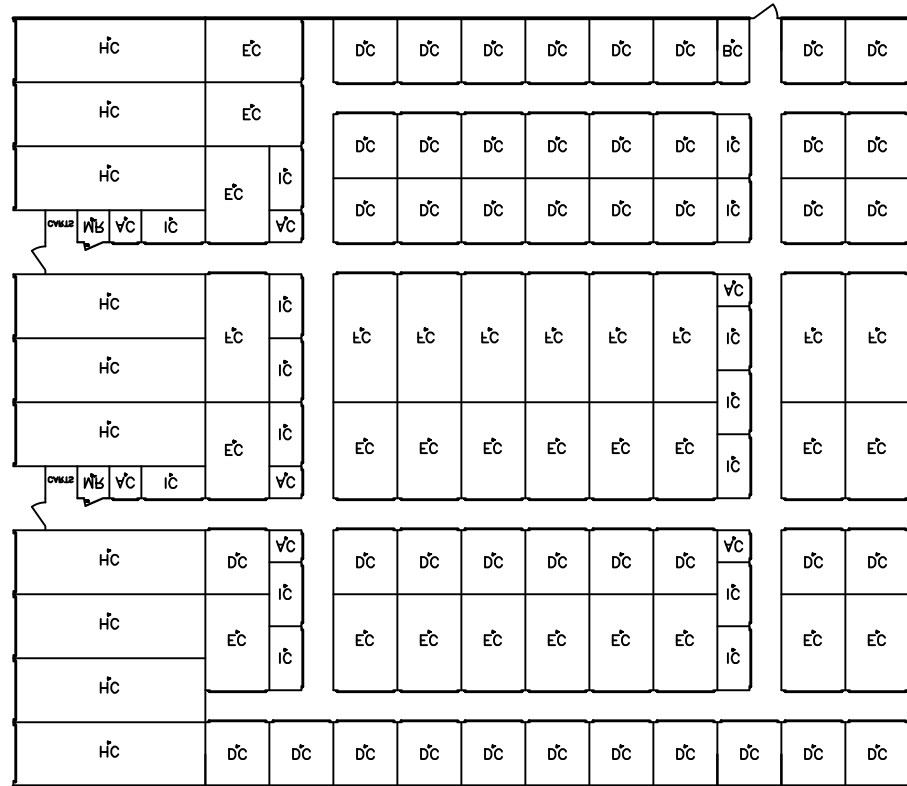


Building #1		Climate Control								Total Units
		5x5 "AC"	5x10 "BC"	10x5 "IC"	5x15	10x10 "DC"	10x15 "EC"	10x20 "FC"	10x30 "HC"	
Total Units Provided		7	1	15	0	44	21	9	10	107
% Provided		6.5%	0.9%	14.0%	0.0%	41.1%	19.6%	8.4%	9.3%	
Building #2		Climate Control								Total Units
		5x5 "A"	5x10 "B"	5x10 "BC"	5x15 "C"	10x10 "D"	10x15 "E"	10x20 "F"	10x30 "H"	
Total Units Provided		6	0	3	4	14	17	1	0	45
% Provided		5.6%	0.0%	2.8%	3.7%	13.1%	15.9%	0.9%	0.0%	
Building #3		Climate Control								Total Units
		5x5 "AC"	5x10 "BC"	10x5 "IC"	10x10 "DC"	10x15 "EC"	10x20 "FC"	10x30 "HC"	12x30 "LC"	
Total Units Provided		3	11	3	34	8	21	5	5	90
% Provided		2.8%	10.3%	2.8%	31.8%	7.5%	19.6%	4.7%	4.7%	


- PROPOSED FEATURES LEGEND
- NEW HEAVY DUTY CONCRETE PAVEMENT AREA
 - NEW HMA PAVEMENT AREA
 - NEW LIGHT DUTY CONCRETE SIDEWALK AREA

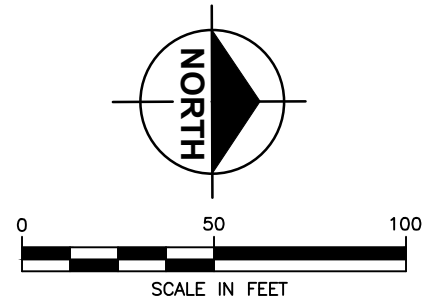

BUILDING 1

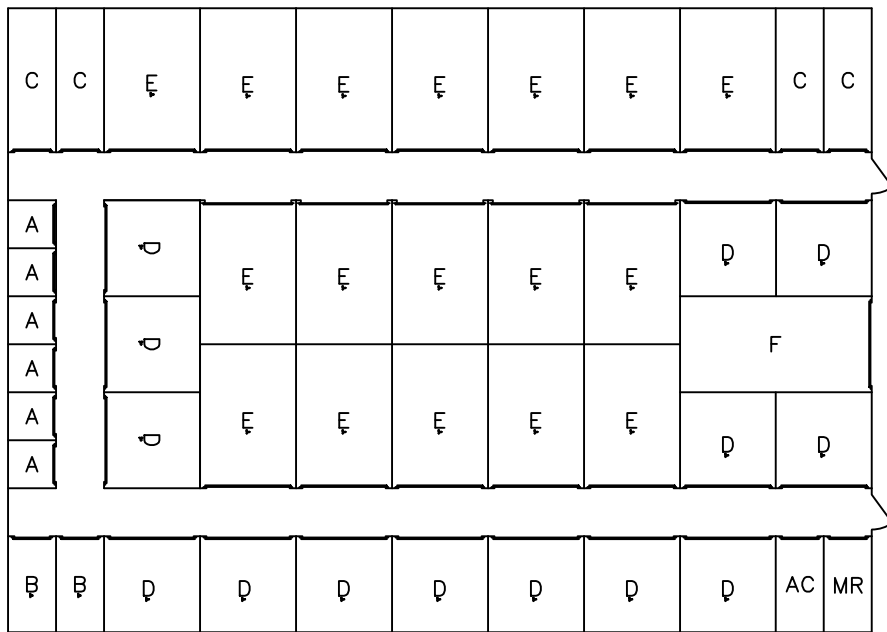


BUILDING 2

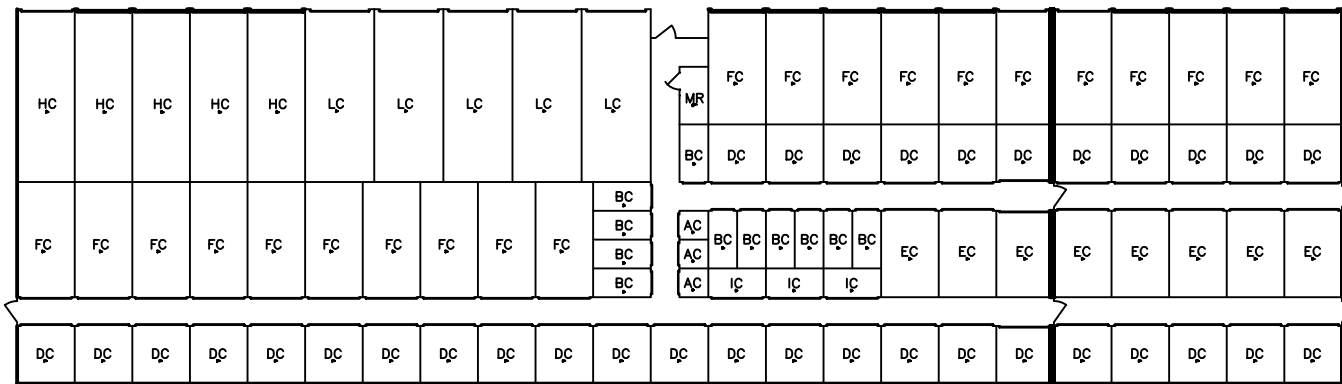

BUILDING 3



Know what's below.
Call before you dig.

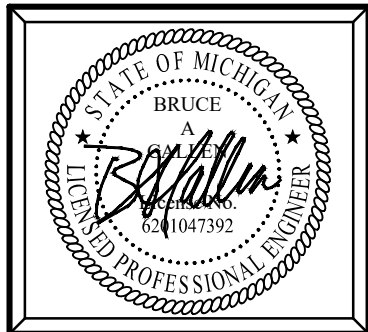

Plan Prepared By:
Bruce A. Callen, PE
Callen Engineering, Inc.
108 E. Savidge St.
Spring Lake, Michigan 49456
Tel: 616-414-5260
email: bcallen@callenengineering.com

For protection of underground utilities, the CONTRACTOR shall dial 1-800-482-7171 OR 811 a minimum of three working days, excluding Saturdays, Sundays and holidays, prior to excavation in the vicinity of utility lines. All "MISS DIG" participating members will thus be routinely notified. This does not relieve the CONTRACTOR of the responsibility of notifying the utility owners who may not be part of the "MISS DIG" alert system.

DATE OF PLAN: 05-16-25

NO.	ISSUANCE / REVISION	BY	DATE
1.	ZONING COMPLIANCE REVIEW	B.A.C.	05-16-24
2.	SITE PLAN REVIEW	B.A.C.	05-14-25
3.	SITE PLAN REVIEW	B.A.C.	05-16-25

DRAWN BY J.W.C.	DATE MAY '24
ENGINEER B.A.C.	DATE MAY '24
EDIT J.W.C.	DATE MAY '25
SCALE DRAWING AS NOTED	PILOT SCALE 1:1
PROJECT 023 SCHURING STORAGE	SHEET NO. C1.0